

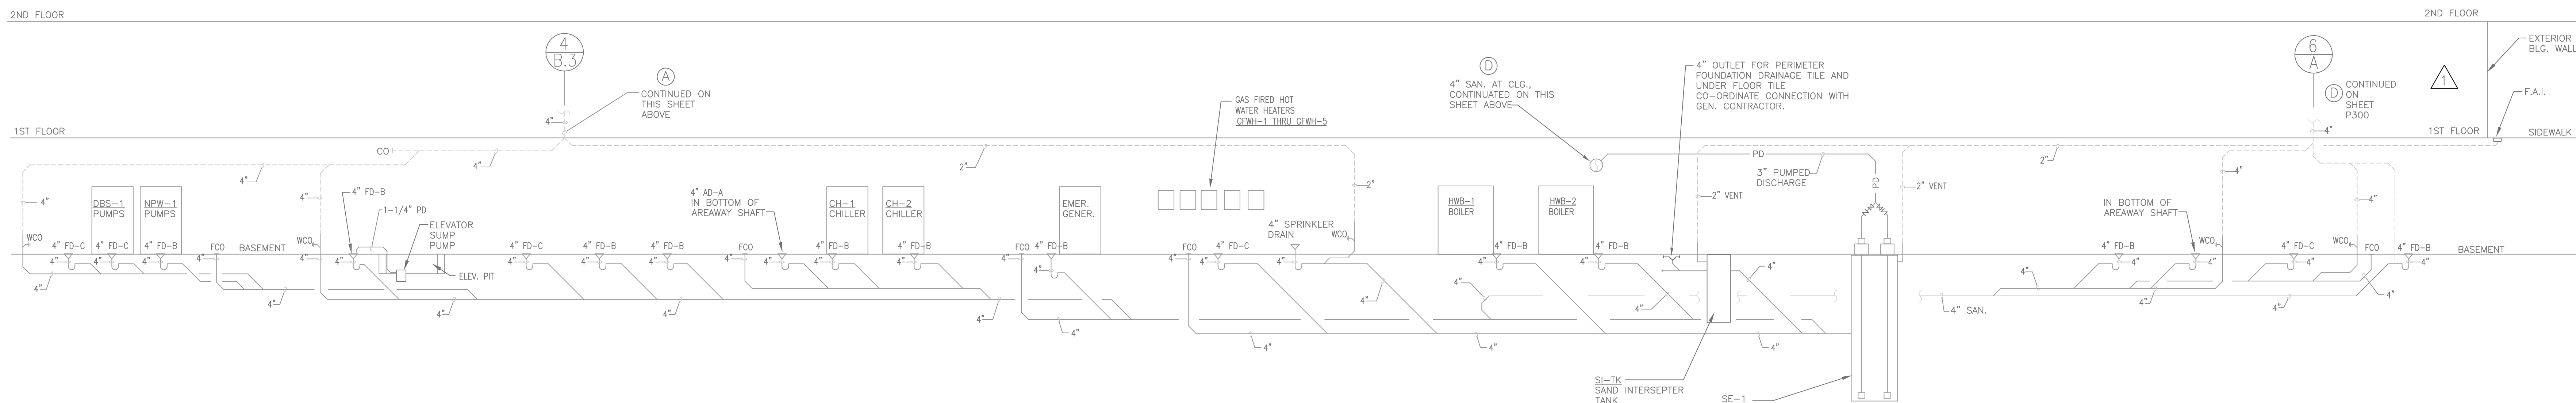
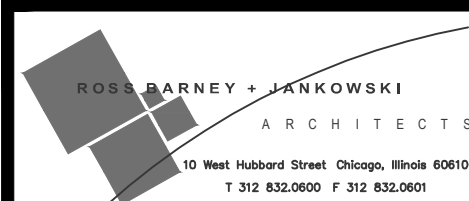


1 SANITARY SCHEMATIC RISER  
N.T.S.

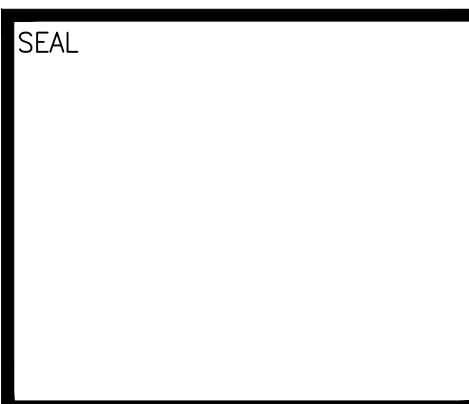

1 SANITARY SCHEMATIC RISER  
N.T.S.

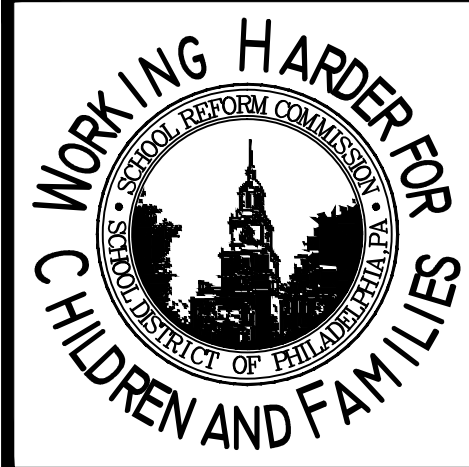

SCHOOL & LOCATION	Commodore John Barry Elementary School 5900 Race Street, Philadelphia PA 19139
PROJECT TITLE	NEW CONSTRUCTION
DRAWING TITLE	SANITARY RISER DIAGRAM
APPROVED BY	

SCHOOL DISTRICT OF PHILADELPHIA THE SCHOOL REFORM COMMISSION	DEPARTMENT OF DESIGN AND CONSTRUCTION SERVICES
1315 Market Street PHILADELPHIA, PA 19107 (215) 400-7730 FAX (215) 400-4731	1315 Market Street PHILADELPHIA, PA 19107 (215) 400-7730 FAX (215) 400-4731

NO.	DATE	REVISION
1	1/17/07	ADDENDUM No. 1

SPEC. NO.	B-840C of 2005/06	DATE	12/29/06
SCALE	NONE	LOCATION NO.	120
DRAWN BY	SGC	TYPE NO.	-
CHECKED BY	ND	FILE NO.	-

DRAWING NO.	P301
-------------	------